



The City of **WORCESTER**

Administration & Finance – Purchasing Division
Christopher J. Gagliastro, MCPPO – Purchasing Director
455 Main Street, Room 201, Worcester, MA 01608
P | 508-799-1220
purchasing@worcesterma.gov

May 31, 2023

To All Bidders:

Subject: **Bid No. 8022-W3, Temporary Chiller Installation – WPD HQ / DPF**

ADDENDUM NO. 1

To Whom It May Concern:

With reference to our bid request relative to the above subject, please refer to the changes/modifications/clarifications to the original proposal request.

- **PLEASE FIND BELOW/ATTACHED GENERAL BID CLARIFICATIONS INCLUDING UPDATED DRAWING A2.01**

Changes to project manual:

Section 05 12 00 – Structural Steel

Item 001 At page 5, add the following Article to Part 3 – Execution:


3.2 Hoisting Steel

A. All hoisting and rigging of structural steel members required for this project shall be provided, furnished and installed in safe conditions. All crane work must include an approved lift plan. Coordinate all crane activity and scheduled with the Owner.


Bidders are requested to acknowledge and/or include this addendum with submission. All other terms, conditions and specifications remain unchanged.

Very truly yours,


Christopher J. Gagliastro
Purchasing Director

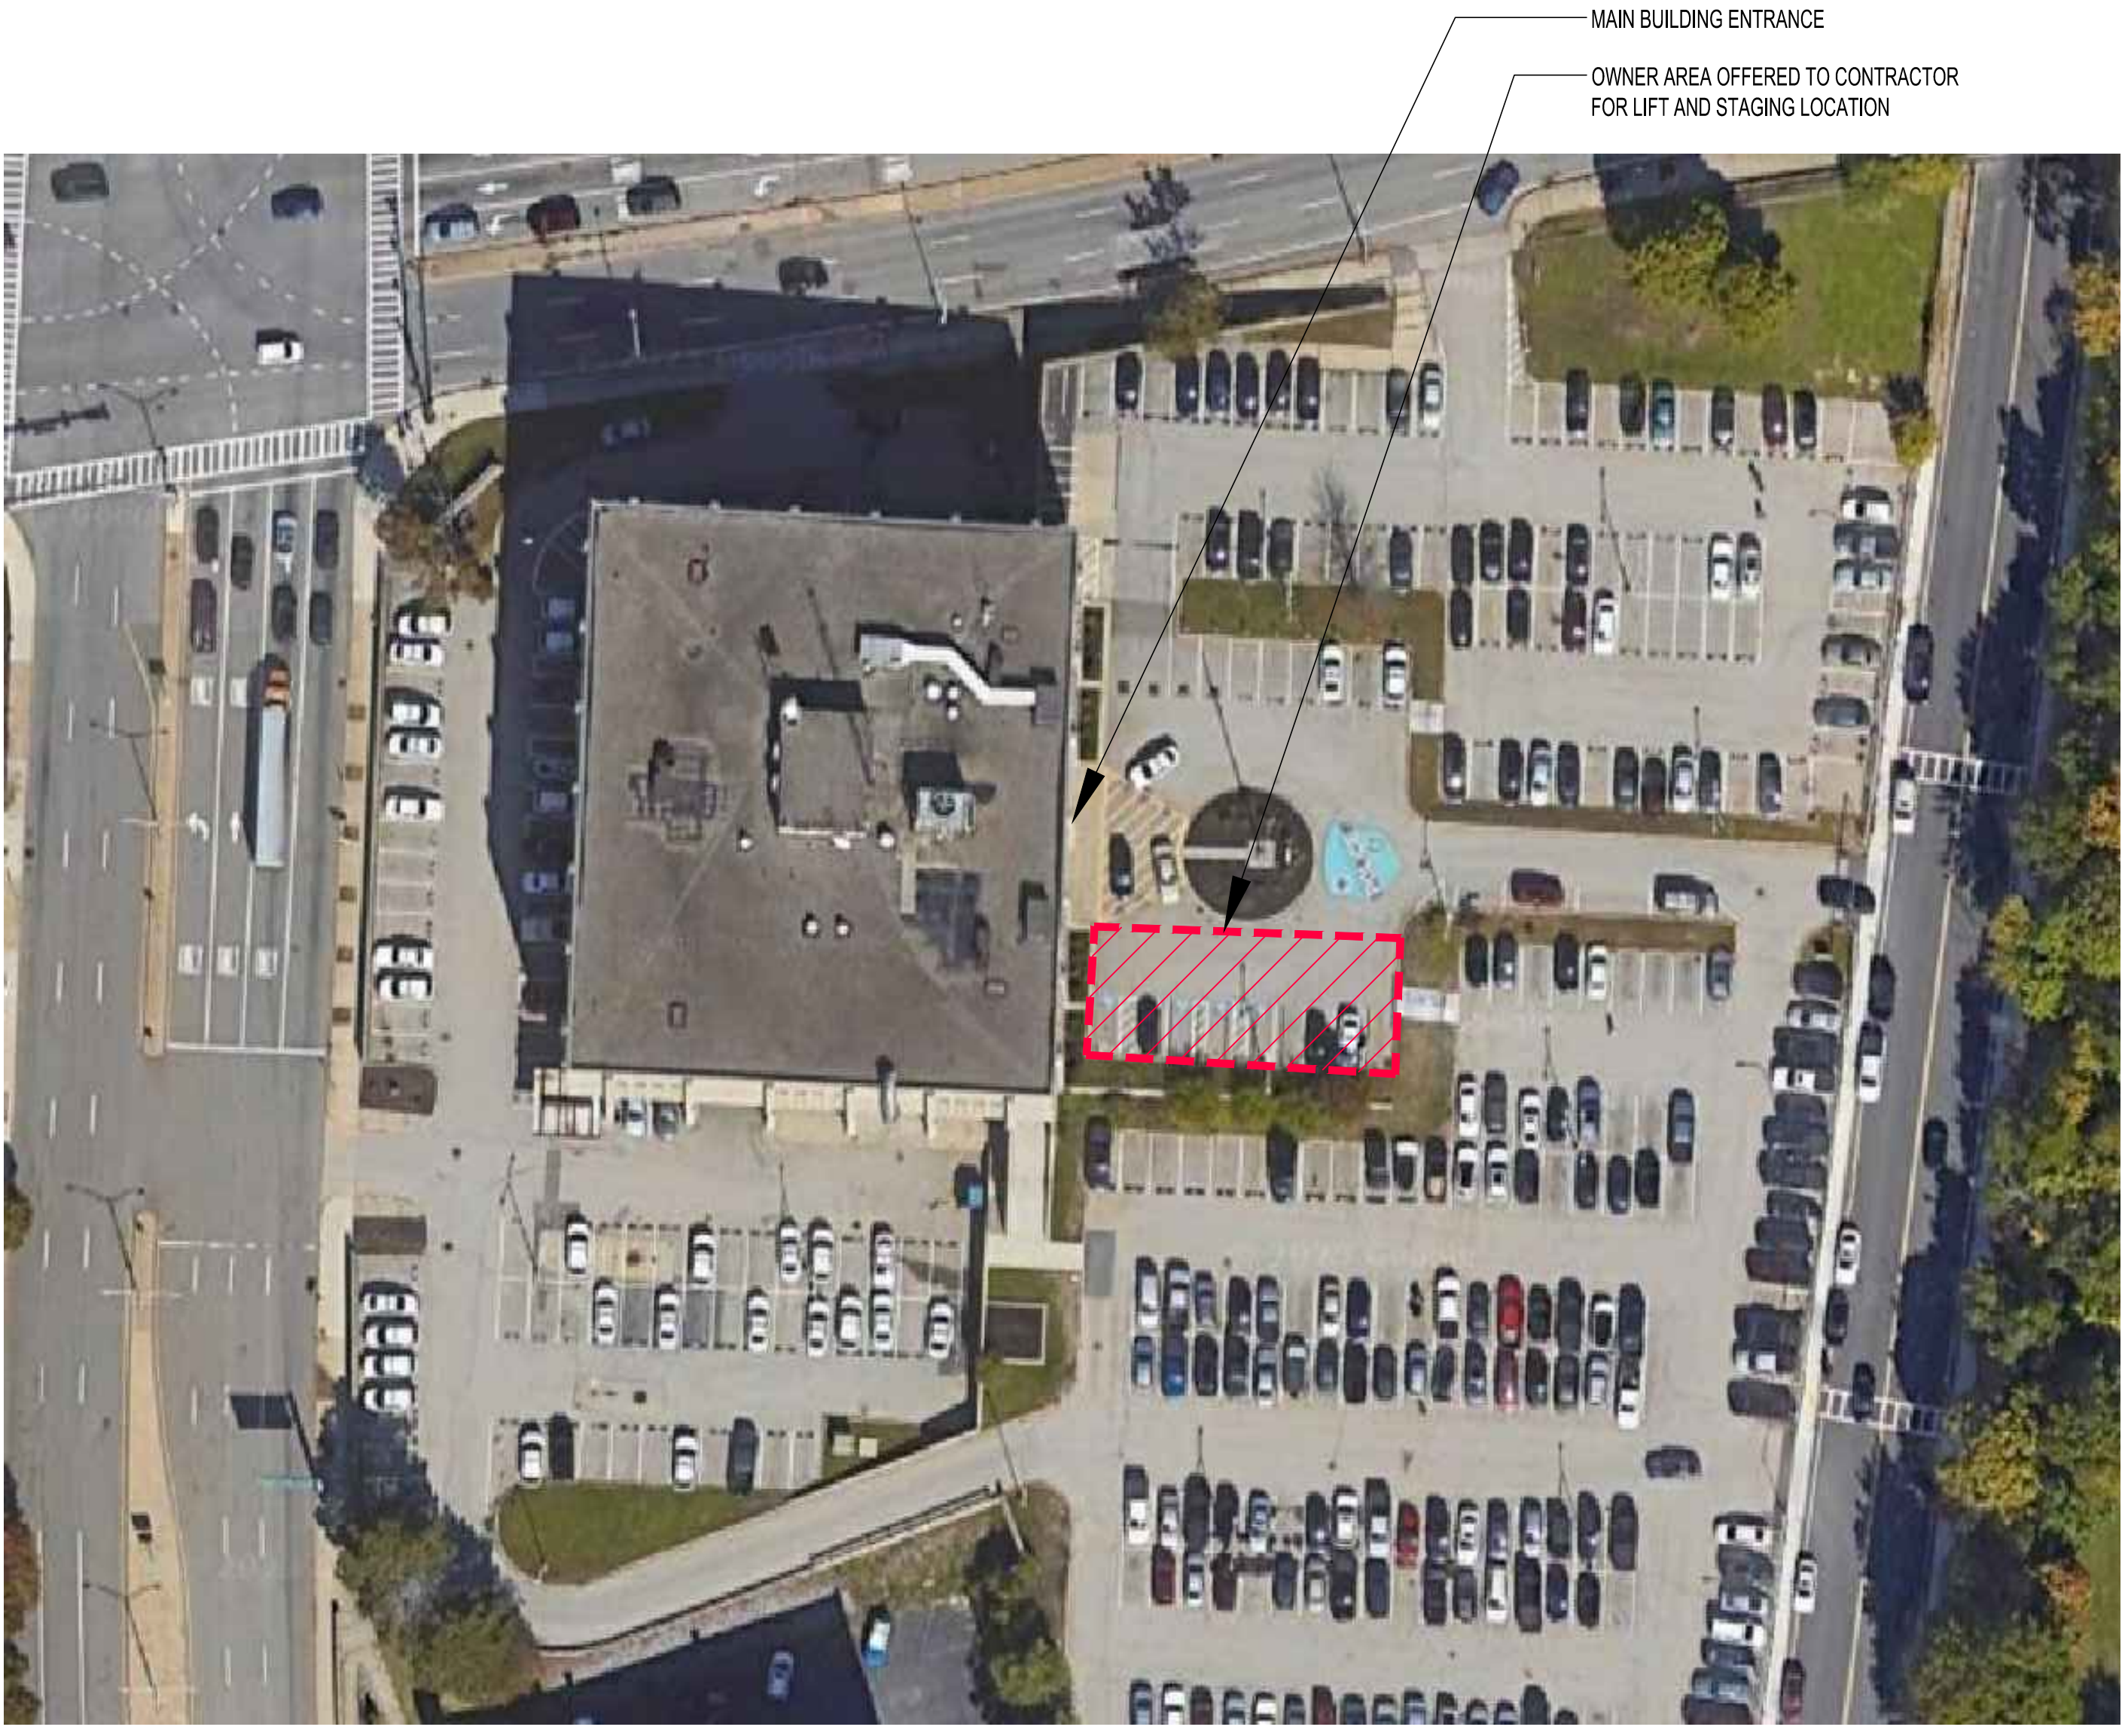


2 PROPOSED CONTRACTOR STAGING AND LIFT AREA PARAMETERS
SCALE: NTS

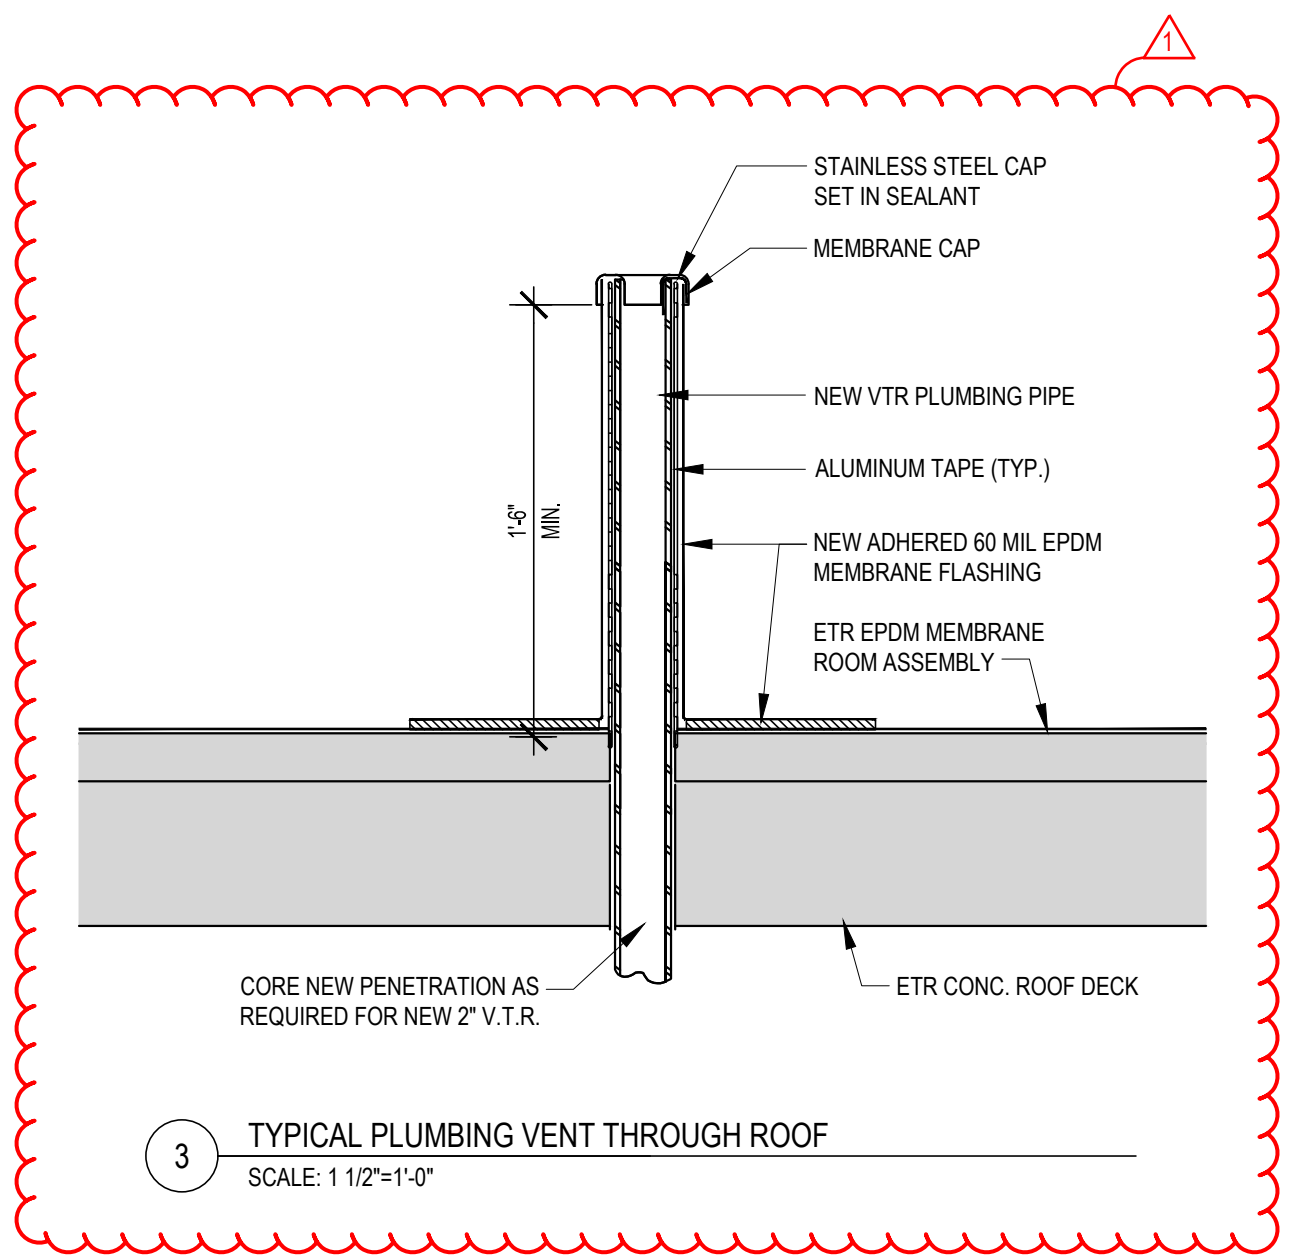

3 TYPICAL PLUMBING VENT THROUGH ROOF
SCALE: 1 1/2"=1'-0"

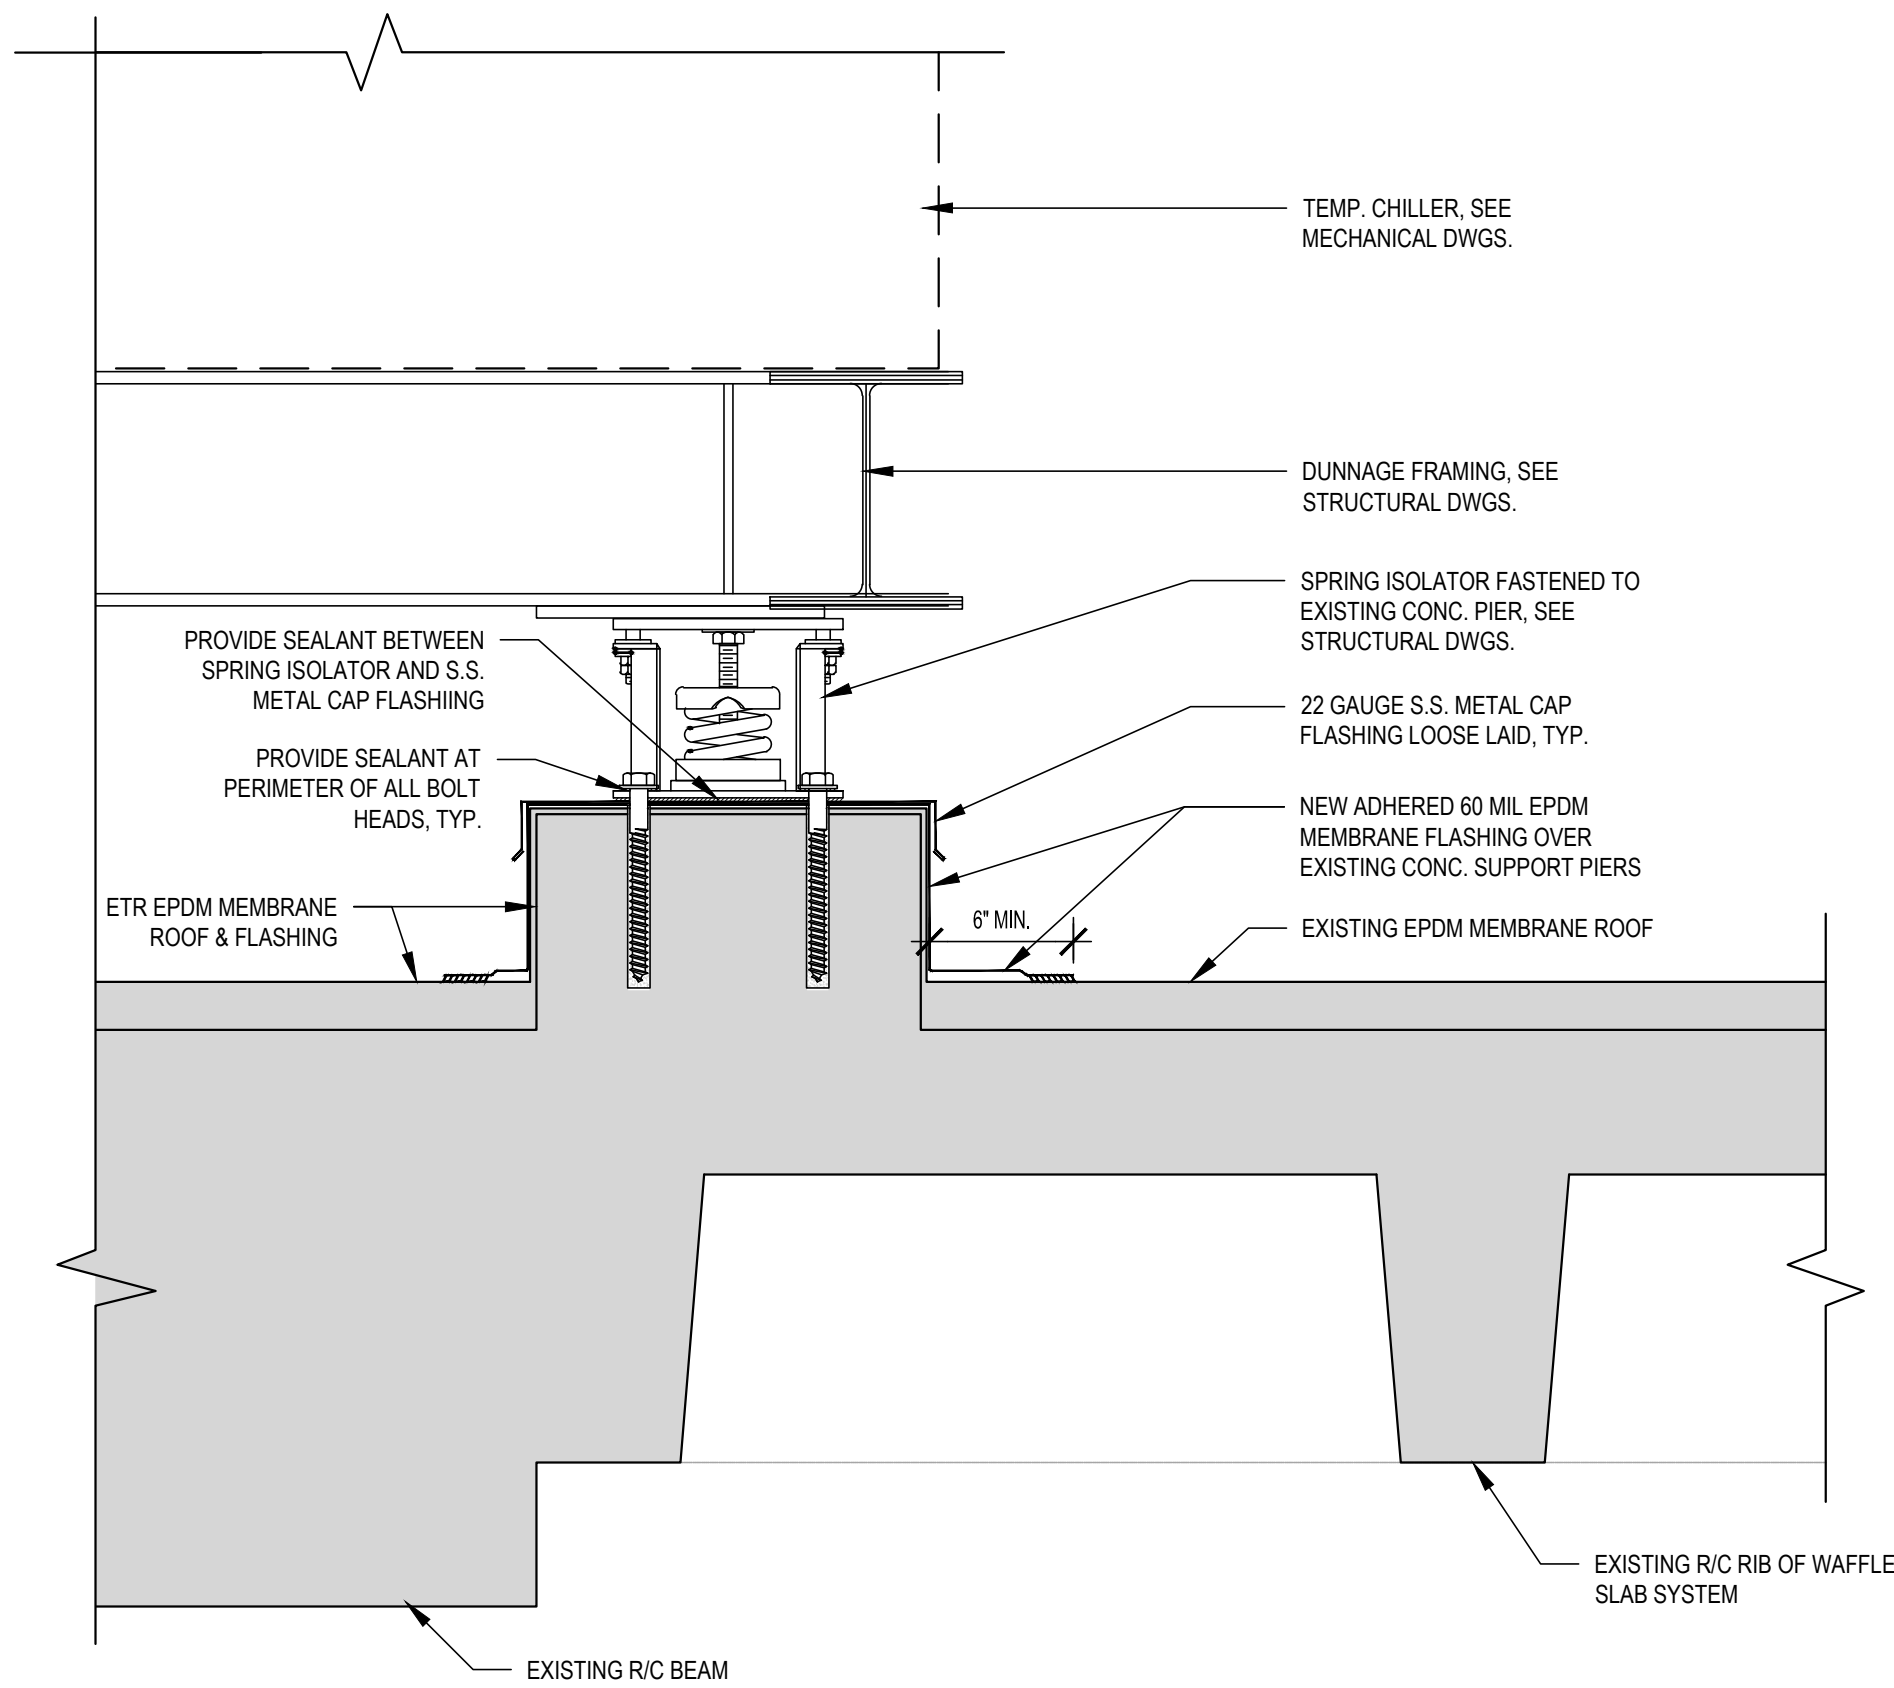

2 FLASHING DETAIL AT EXISTING CONCRETE SUPPORT PIERS (TYPICAL OF 4)
SCALE: 1 1/2"=1'-0"

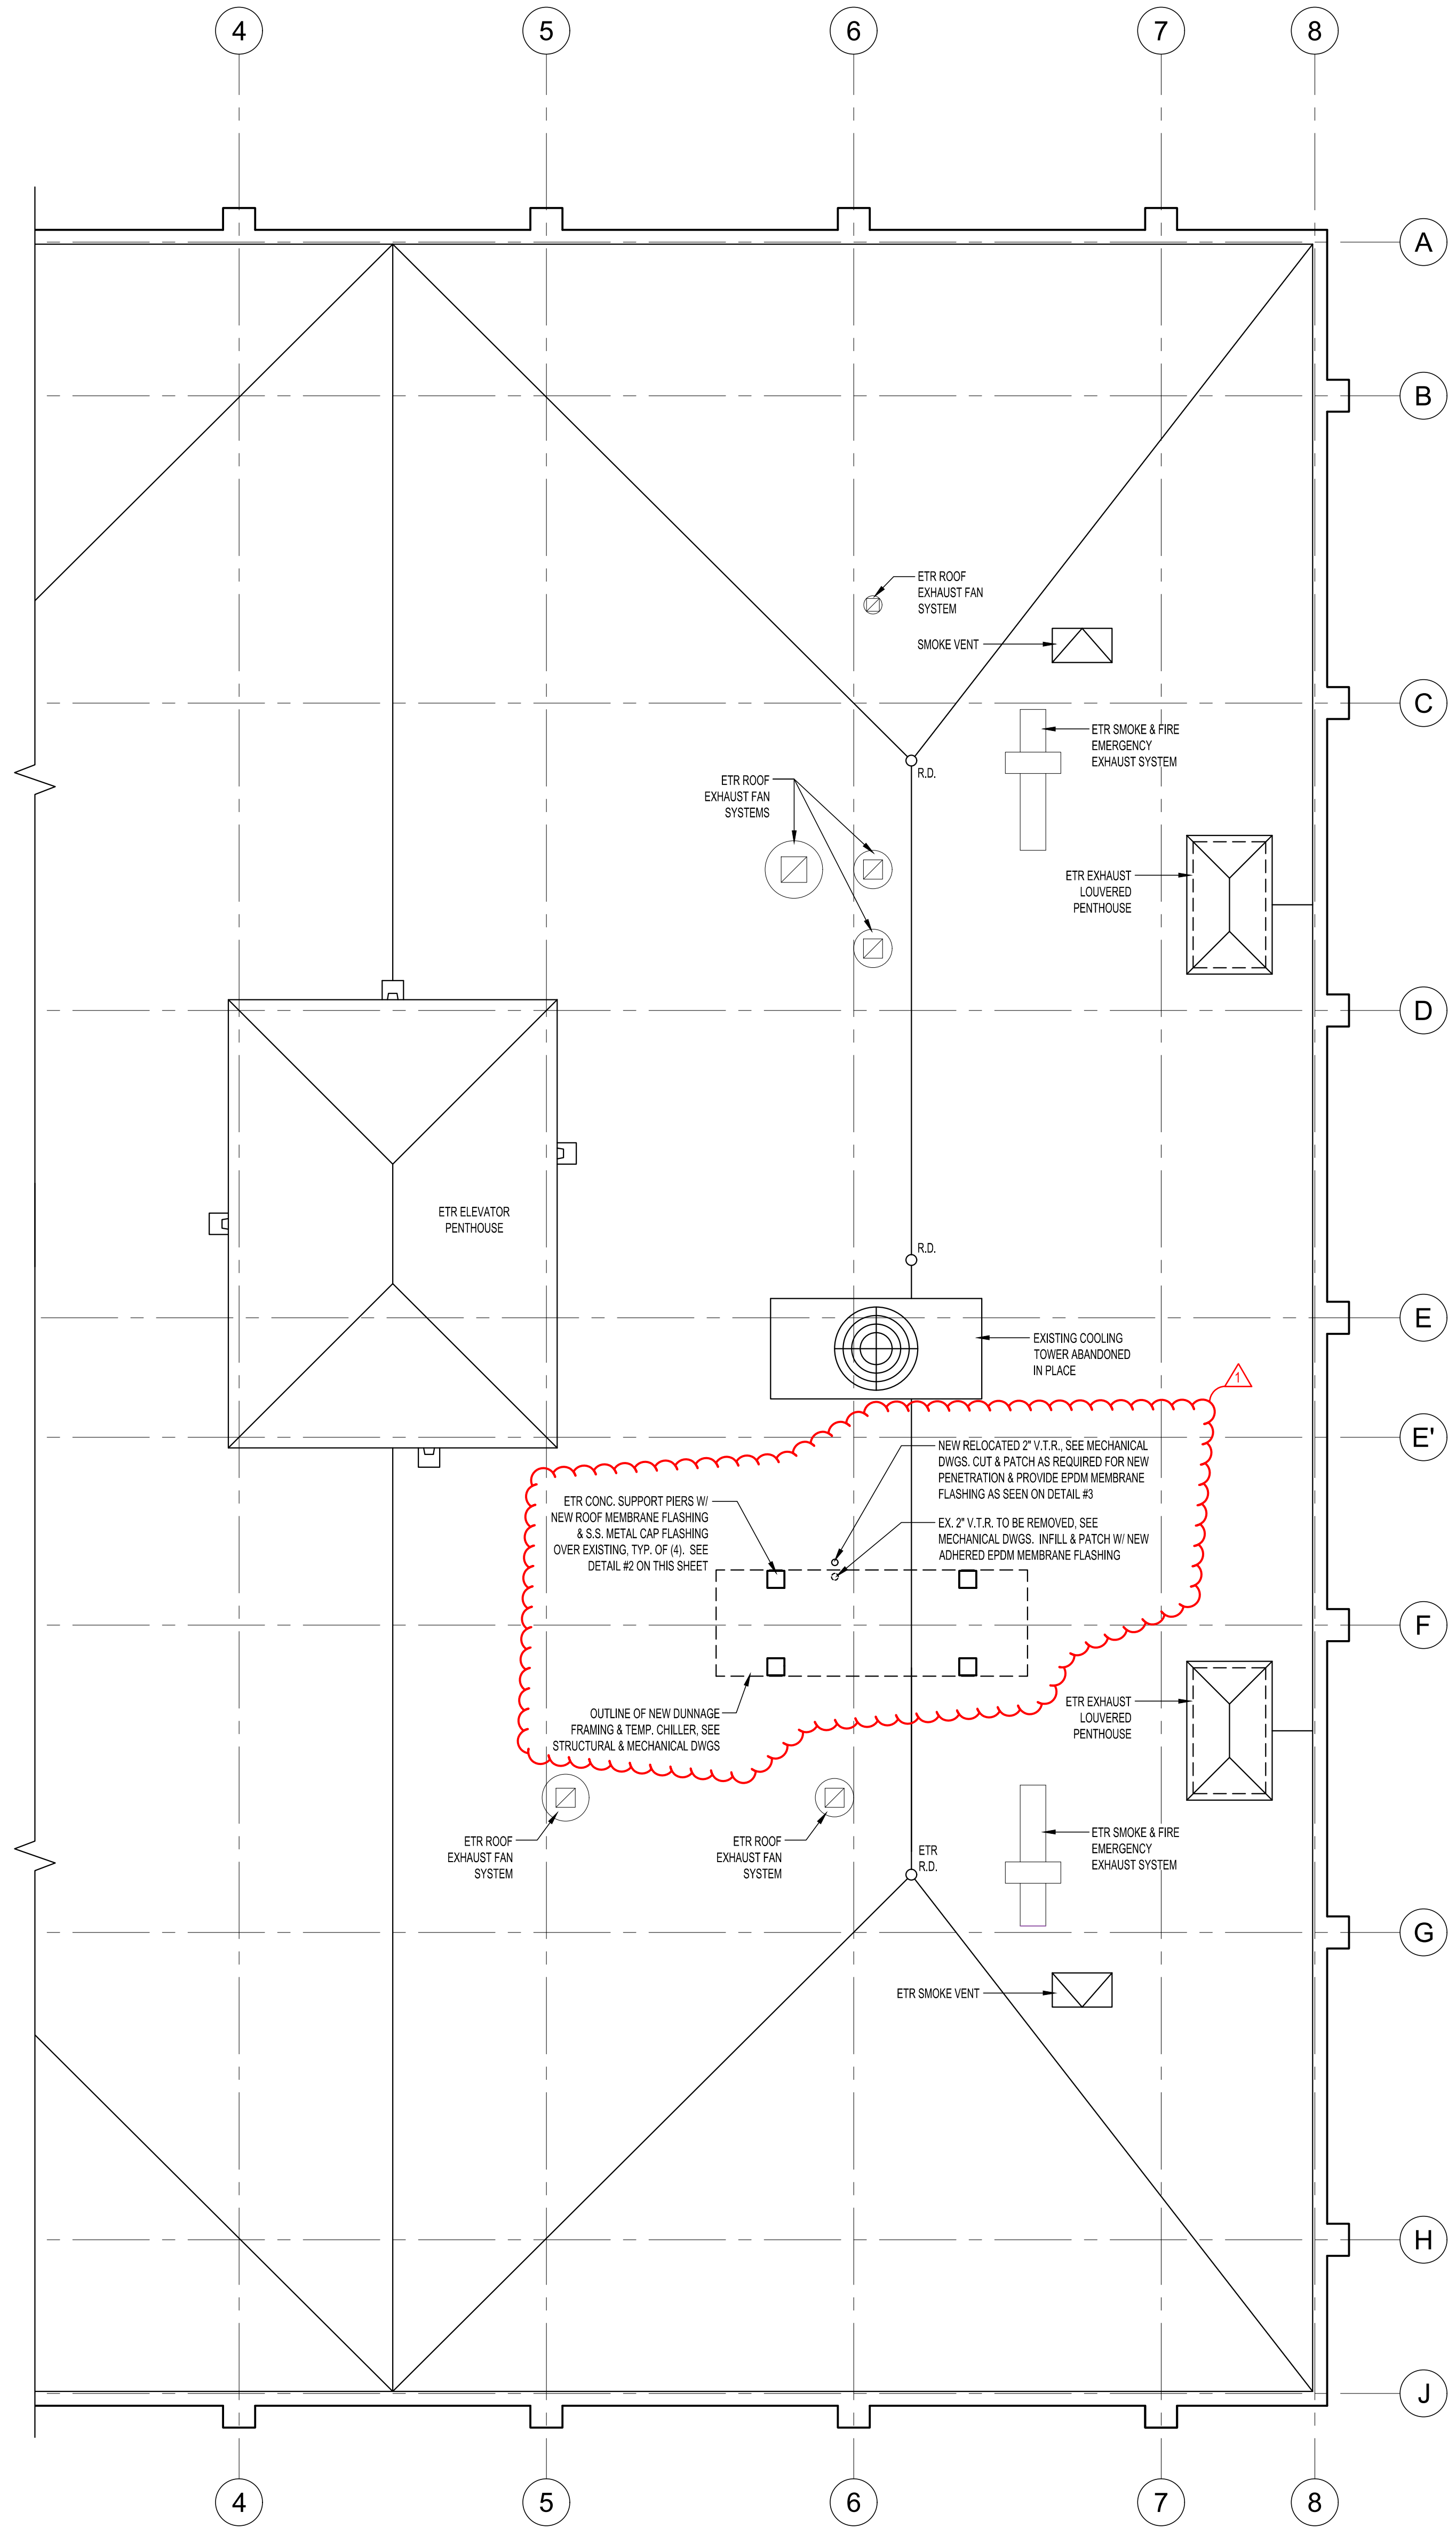

1 ROOF PLAN
SCALE: 1/8"=1'-0"

NORTH ARROW

CONSULTANTS

REVISIONS

ADDENDUM #1 May 31, 2023

PROJECT PHASE

BID SET

PROJECT NUMBER

02023.03

PROJECT NAME/LOCATION

WORCESTER
POLICE
HEADQUARTERS
TEMP. CHILLER
REPLACEMENT

9-11 LINCOLN SQUARE
WORCESTER, MA 01608

DRAWING TITLE

ROOF PLAN,
ROOF DETAIL &
CONTRACTOR STAGING/
LIFT AREA PARAMETERS

MVG
MOUNT VERNON GROUP
ARCHITECTS
178 Albion Street
Suite 240
Wakefield, Massachusetts 01880

781 213 5030 T
781 213 5040 F
info@mvgarchitects.com E

STAMP

DRAWING INFORMATION

SCALE AS INDICATED

DRAWN BY H.C.

CHECKED F.T.

DATE MAY 24, 2023

DRAWING NUMBER

A2.01