



June 25, 2026

To All Bidders:

Subject: **Bid #: CR-8739-W7, Parking Lot Repairs – RECC / DPF**

ADDENDUM NO. 1

To Whom It May Concern:

With reference to our bid request relative to the above subject, please refer to the changes/modifications/clarifications to the original request.

PLEASE SEE BELOW GENERAL BID CLARIFICATIONS INCLUDING QUESTIONS RECEIVED AND RESPONSES FROM CITY

Question 1: Step #4 of the Scope of Work states to use a rubberized sealer with a 5-year product warranty. I do not believe this material exists with such a warranty, nor can I supply one. If the owner has a particular suggested product, please provide this information. Otherwise, can the warranty be removed and/or changed to 1 year (with no sand used during winter)?

Answer: The request for a 5 Year product warranty shall be removed. The quality of workmanship shall meet a 1-year warranty. Rubberized sealer or coal tar polymer with sand are acceptable products, below are some acceptable manufacturers and products for use.

Dalton Coating - XL 1000AE - <https://daltoncoatings.com>

Sealmaster with sand <https://sealmaster.net/>

Neyra – Tarconite with sand <https://neyra.com/>

Added work

1. Remove weed grass in asphalt cracks prior to crack filling.



Altered work

1. Increase Concrete Trash Truck Pad from 12' x 32' to 12' x 40'.
2. Provide 5 gallons of Attic Stock for asphalt crack sealer and sealant.


Clarification

1. See updated existing underground conduit lighting layout to LP 7 at end of daisy chain wiring. Contractor to own replacement of existing wiring and conduits as required from LP 6 to LP 7.
2. Asphalt crack sealer, sealant and traffic are to be compatible with each other.

Bidders are requested to acknowledge and/or include this addendum with submission. All other terms, conditions and specifications remain unchanged.

Very truly yours

Christopher J. Gagliastro
Purchasing Director

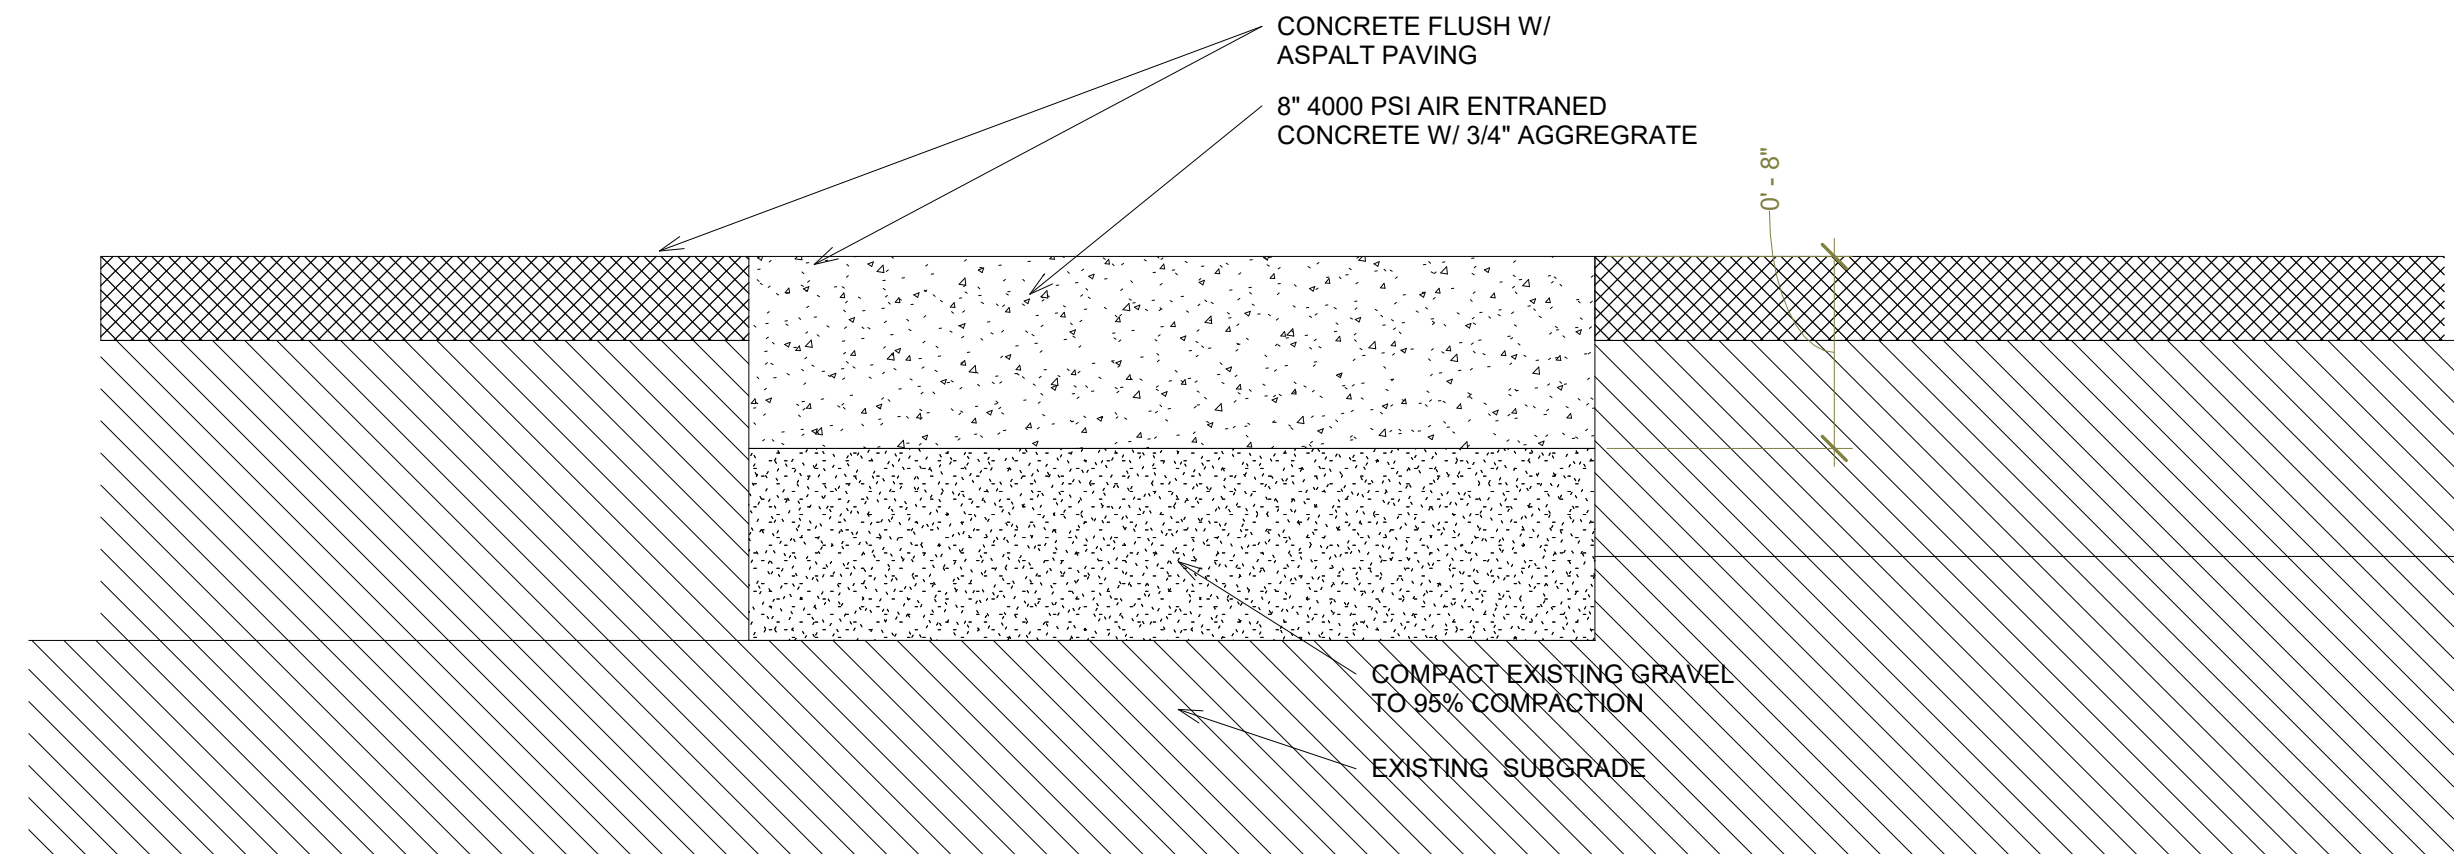


2 Concrete Pad @ Dumpster
1 1/2" = 1'-0"



PHOTO 2



PHOTO 3

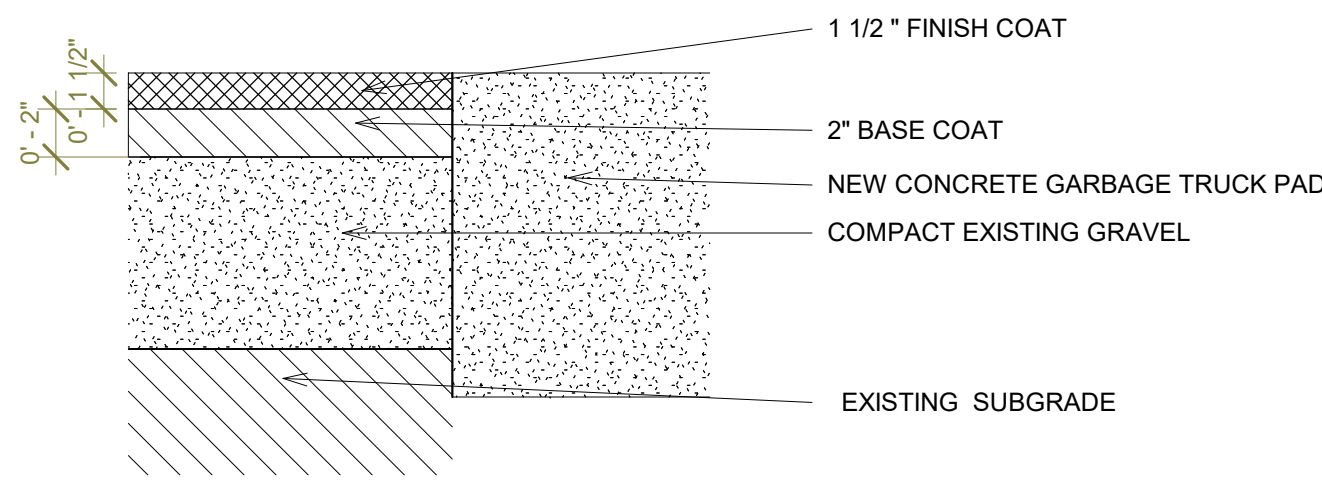

3 Paving Repair Detail at Concrete Pad AS NEEDED
1 1/2" = 1'-0"


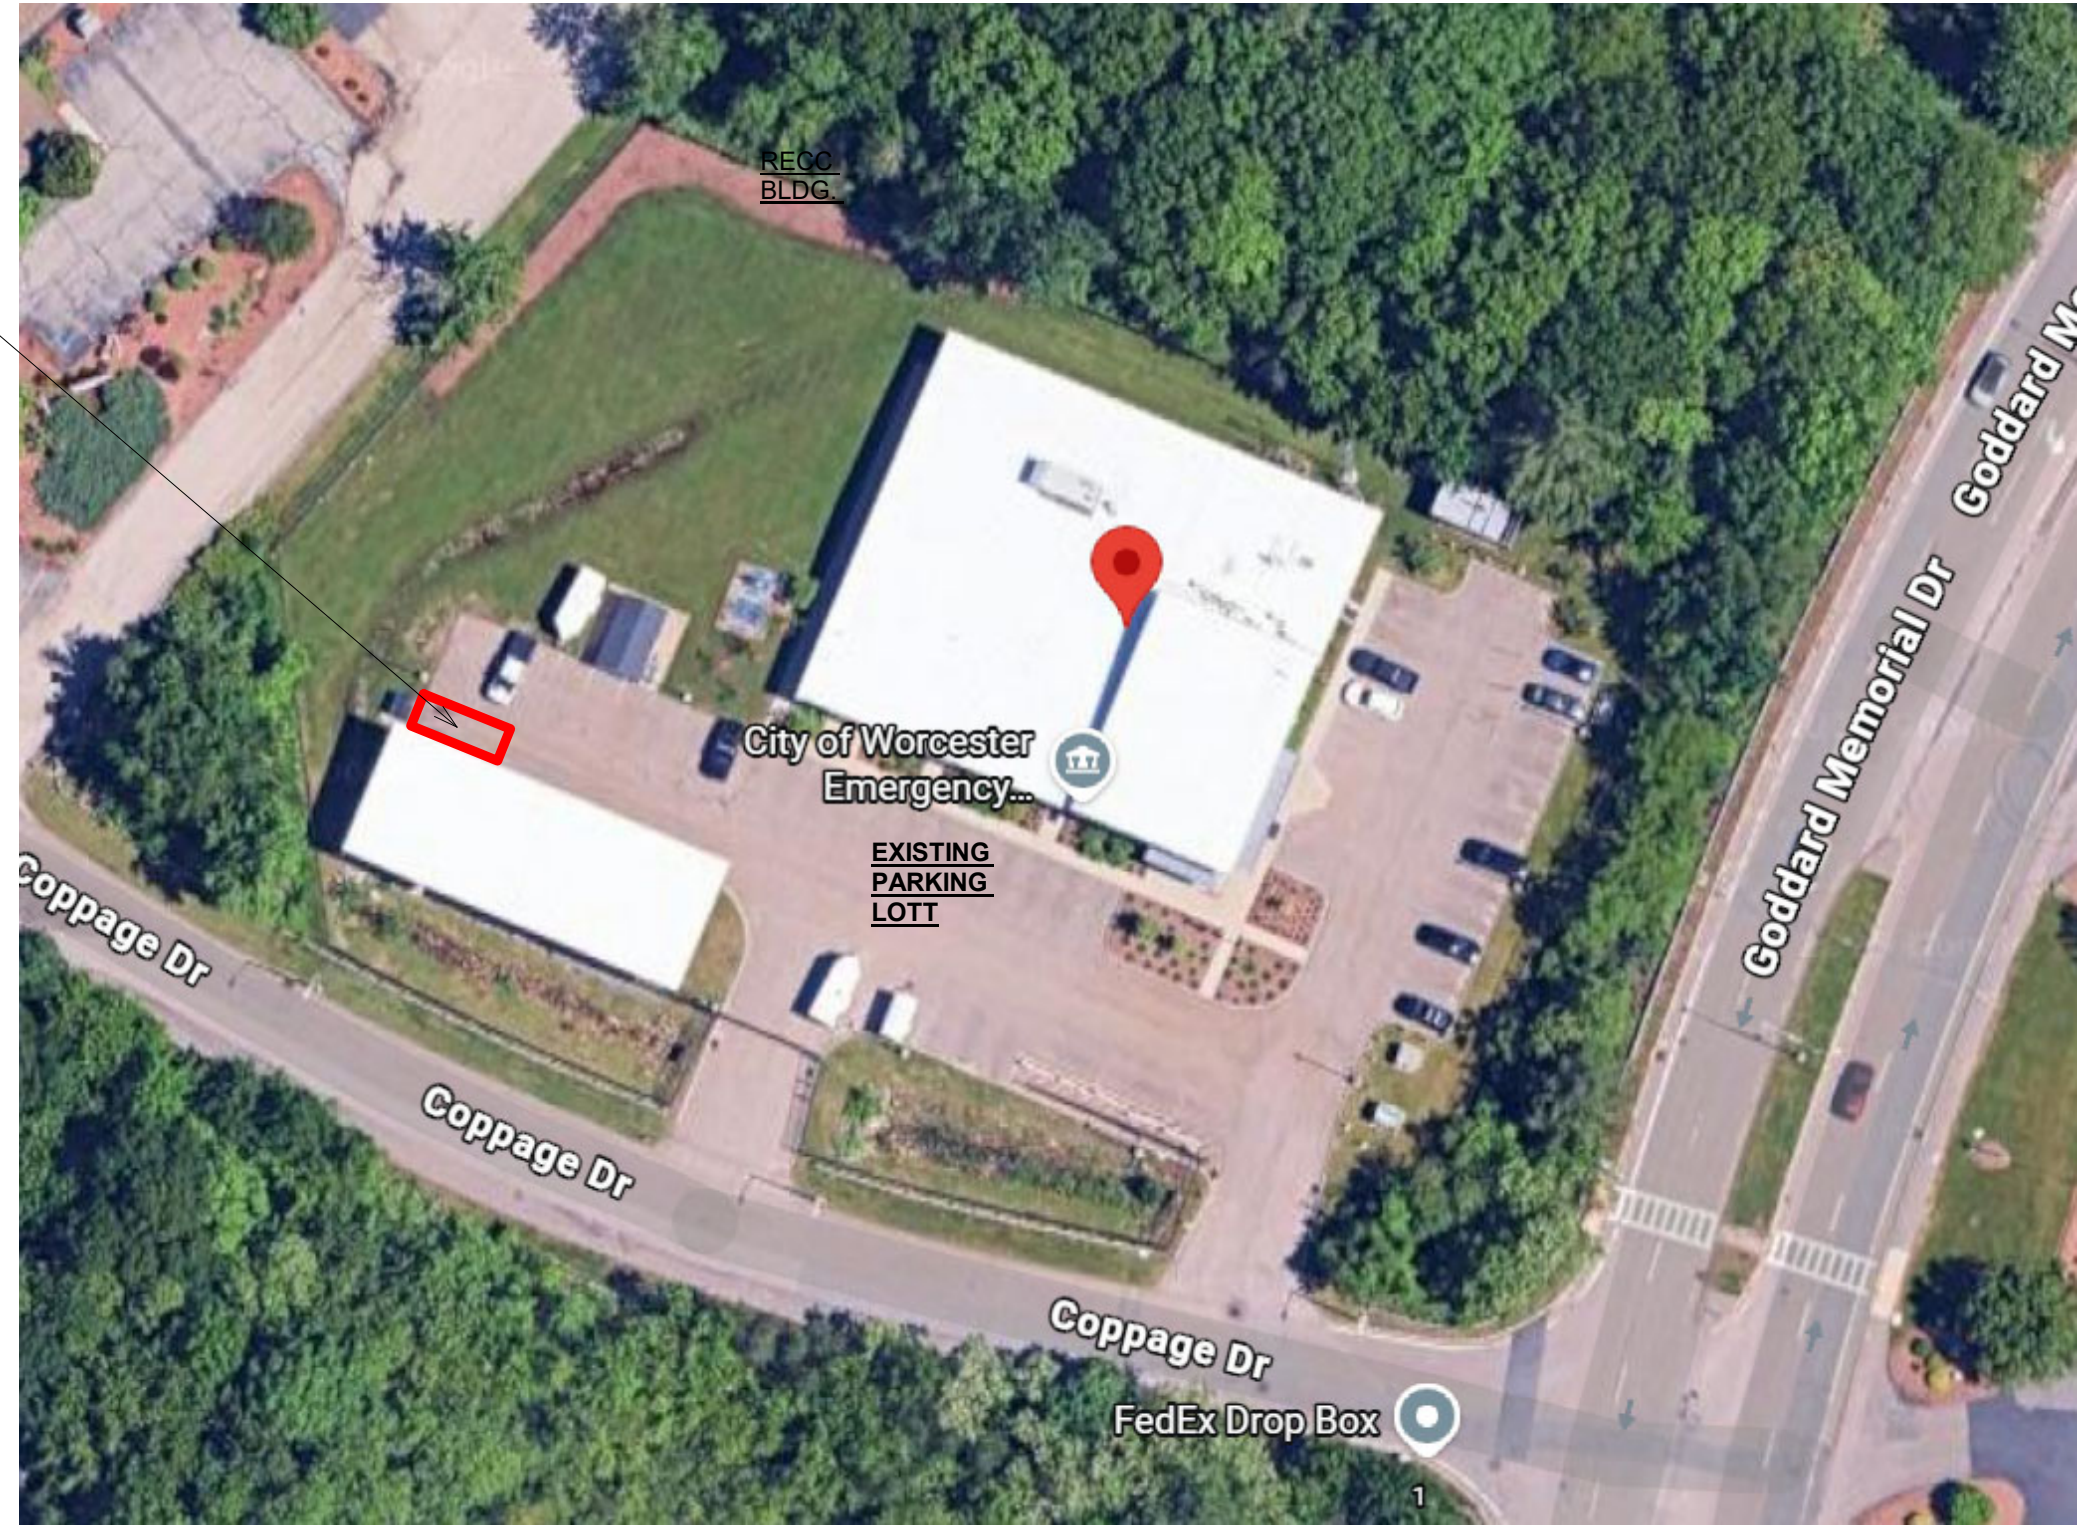


PHOTO 1 - AIREAL PHOTO

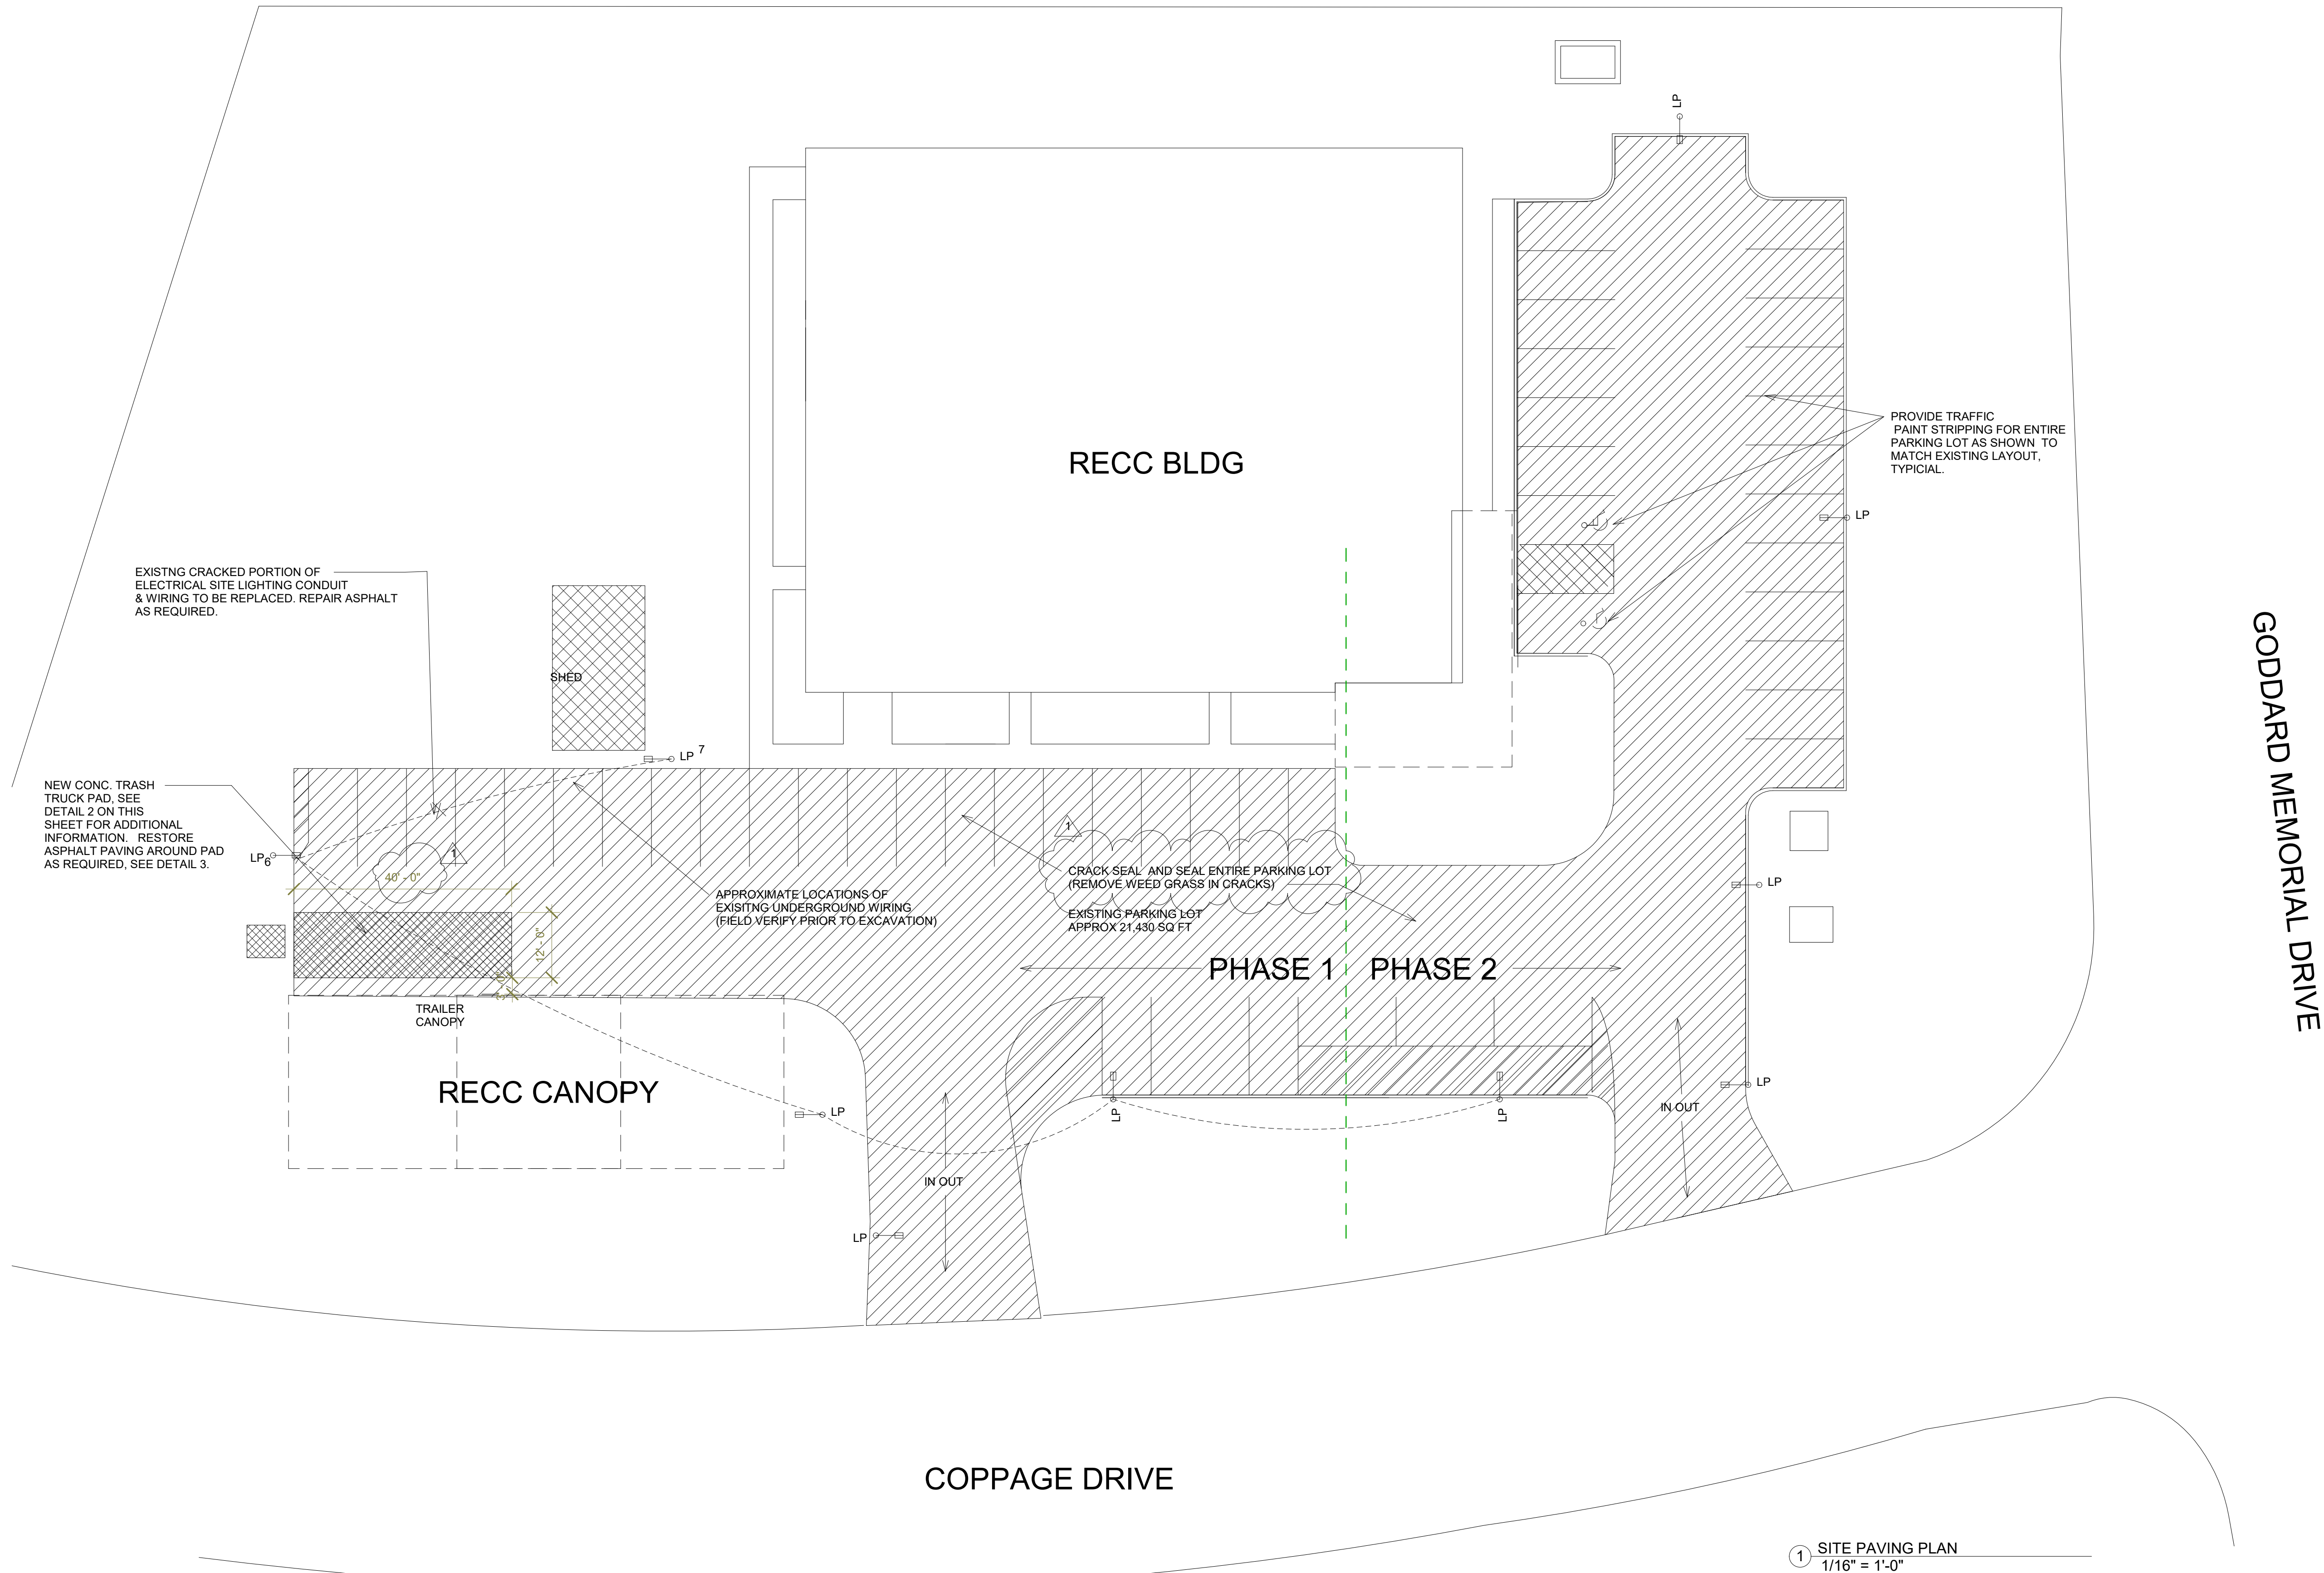

1 SITE PAVING PLAN
1/16" = 1'-0"

REVISIONS	
1	ADDENDUM 1 6/25/26
PLAN NORTH	
KEY PLAN	
ENGINEER	
NOTES:	
OWNER CITY OF WORCESTER	
DEPARTMENT OF PUBLIC FACILITIES	
50 OFFICIER MANNY FAMILIA WAY Worcester, MA 01605	
PROJECT TITLE RECC PARKING LOT REPAIRS AND ALTERATIONS	
2 Coppage Drive Worcester, MA 01603	
DRAWING NAME PARKING PLAN & DETAILS	
DATE	REV 06/26/26
SHEET NUMBER	
A1.1	
SHEET 1 OF 1	